




PLAN VIEW TEA ROOM WATER CASCADE and PLANTER

SCALE: 1/4" = 1'-0"

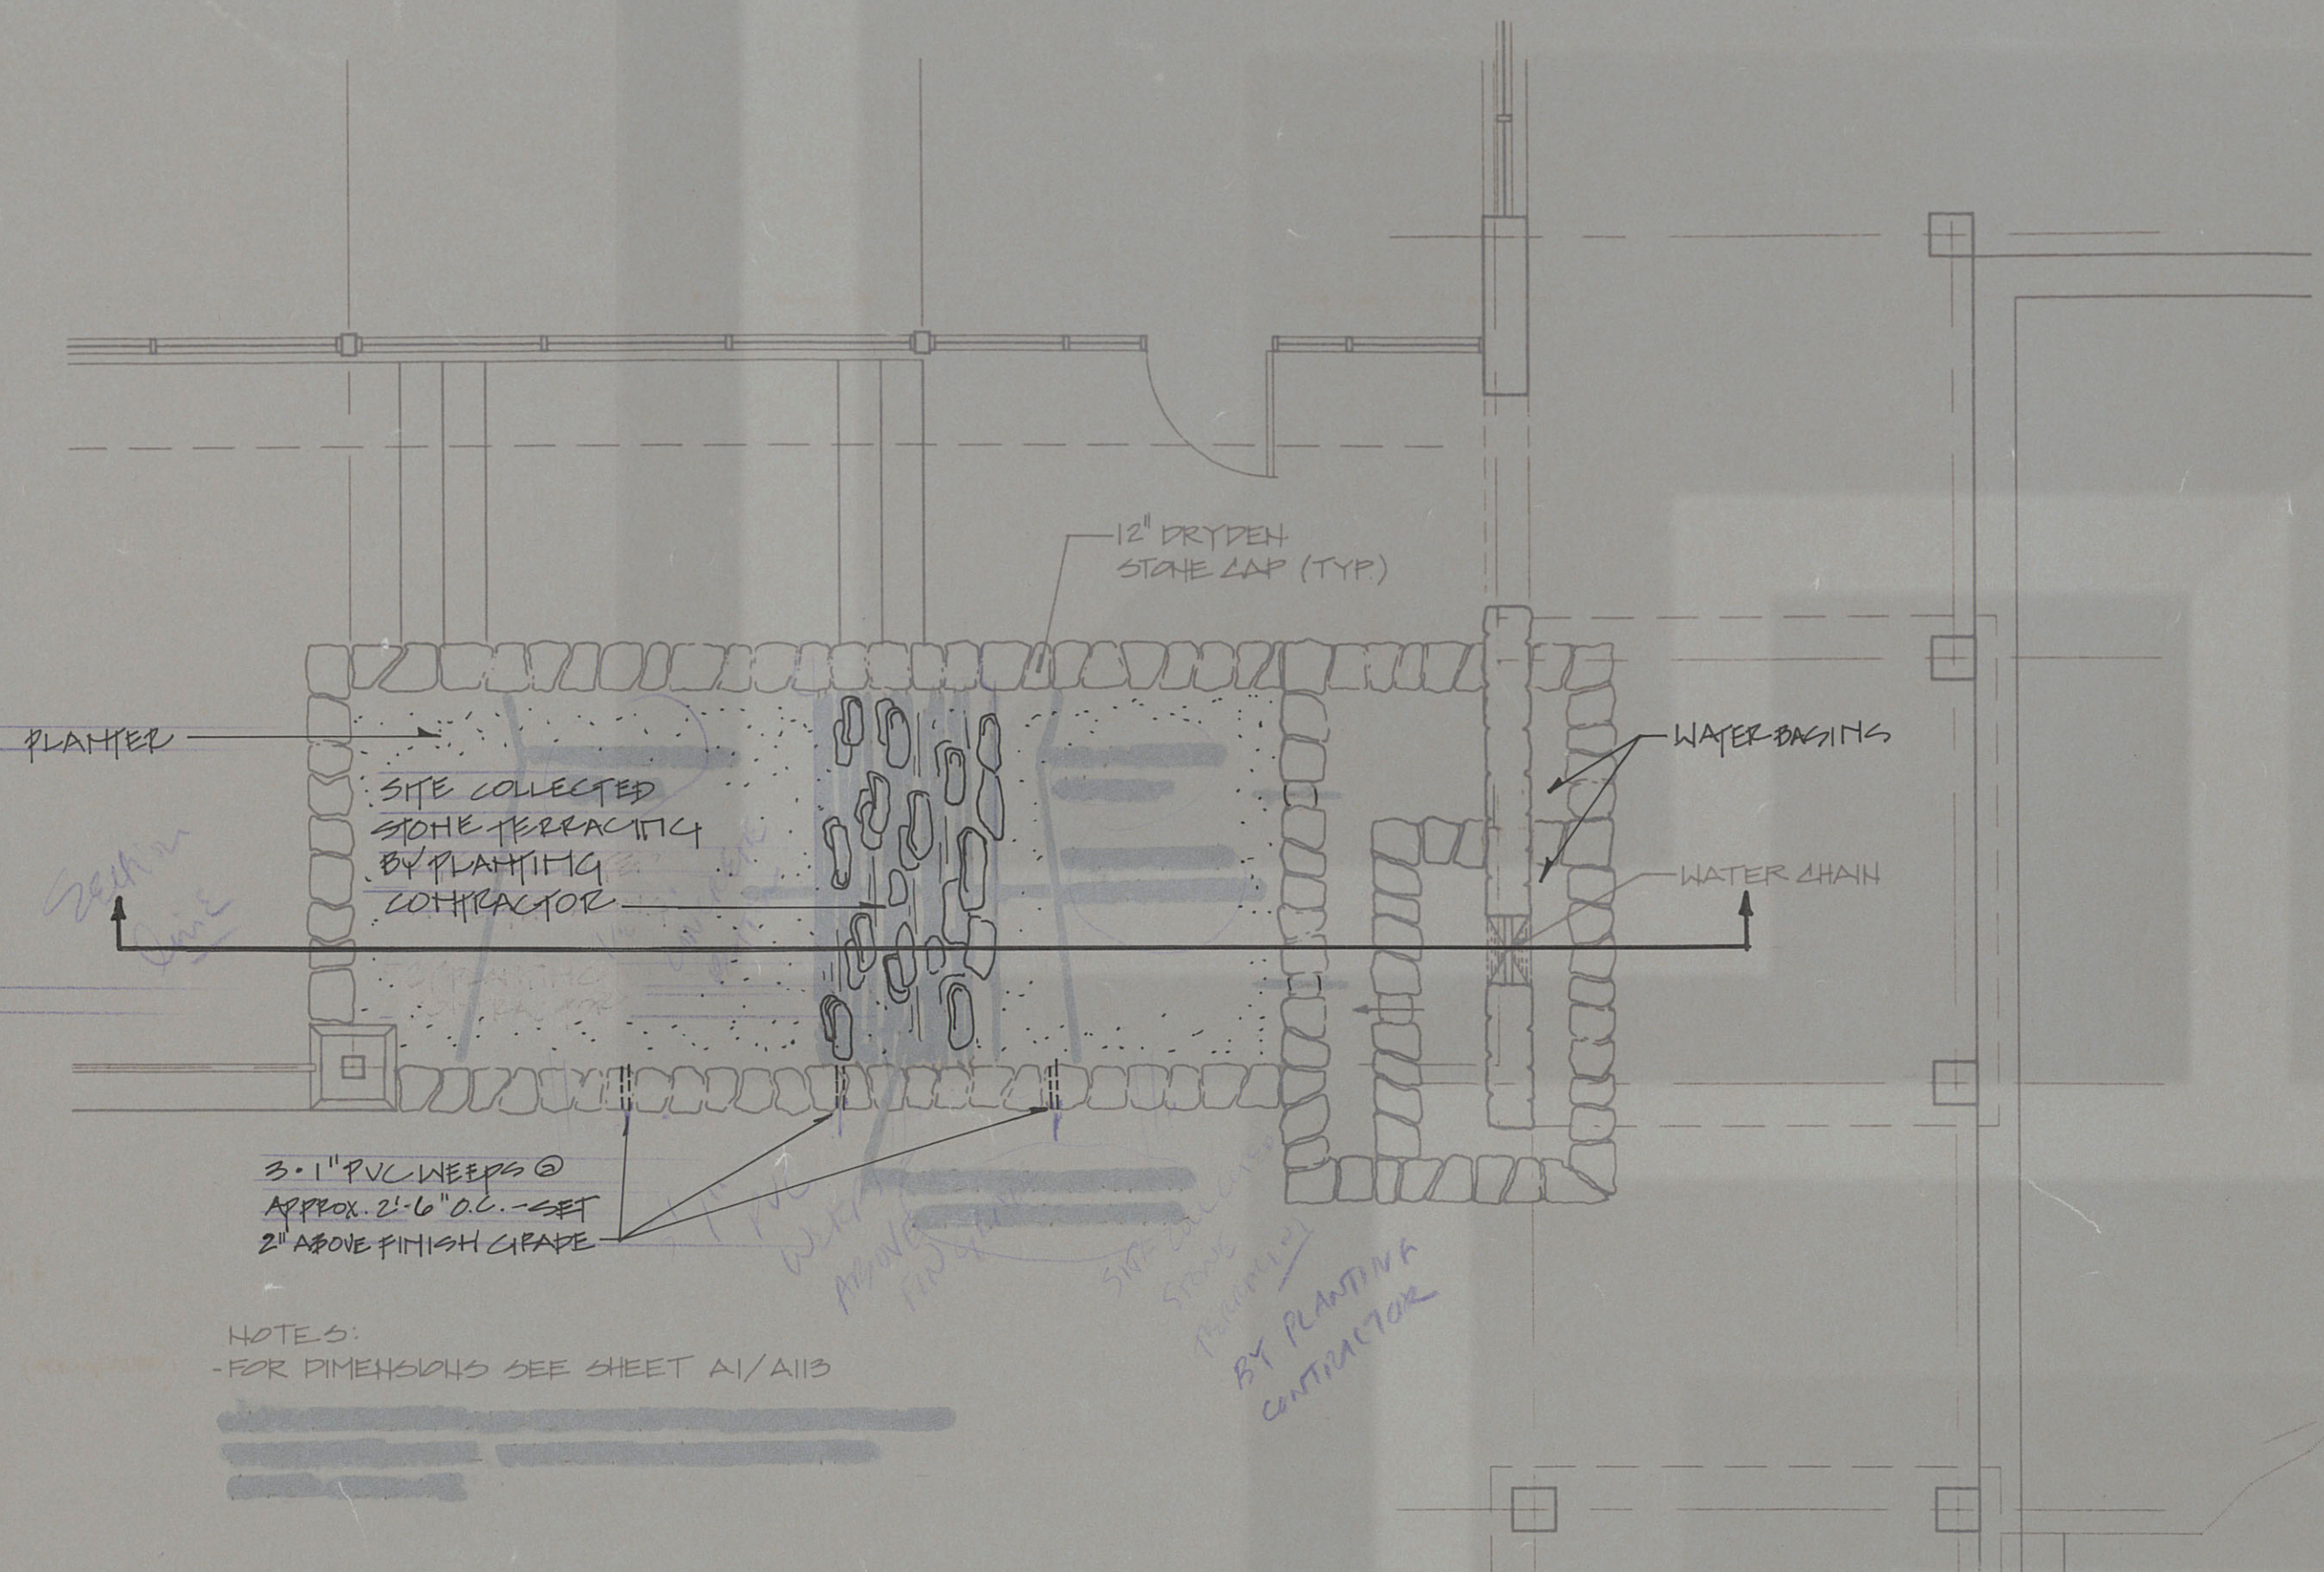

TEA ROOM WATER CASCADE and PLANTER ELEVATION


SCALE: 1/4" = 1'-0"

WATER FEATURE EQUIPMENT LIST TEA ROOM WATER CASCADE

The following water feature equipment shall be provided and installed along with accompanying control valves, PVC piping sized to provide the intended water effects, connections to electric power source, basin construction and any other miscellaneous construction to provide an operating water feature.


All work shall be performed by a qualified pool contractor or masonry contractor experienced in fountain construction. Pool and masonry subcontractors shall coordinate their work closely. All structural steel and concrete work shall conform to N.S.P.I. standards for workmanship and quality. All subcontractors shall be approved by the Landscape Architect prior to beginning work.

1. Pumps: 1.0 H.P., Purex or equal.
2. Filter: 100 to 200 sq. ft. cartridge type, Purex or equal.
3. Chlorinator: inline type
4. Backflow Prevention Device: Fecbo or equal sized to fit
5. Time Clock(s): one electro-mechanical
6. Freeze Protection Device(s): one

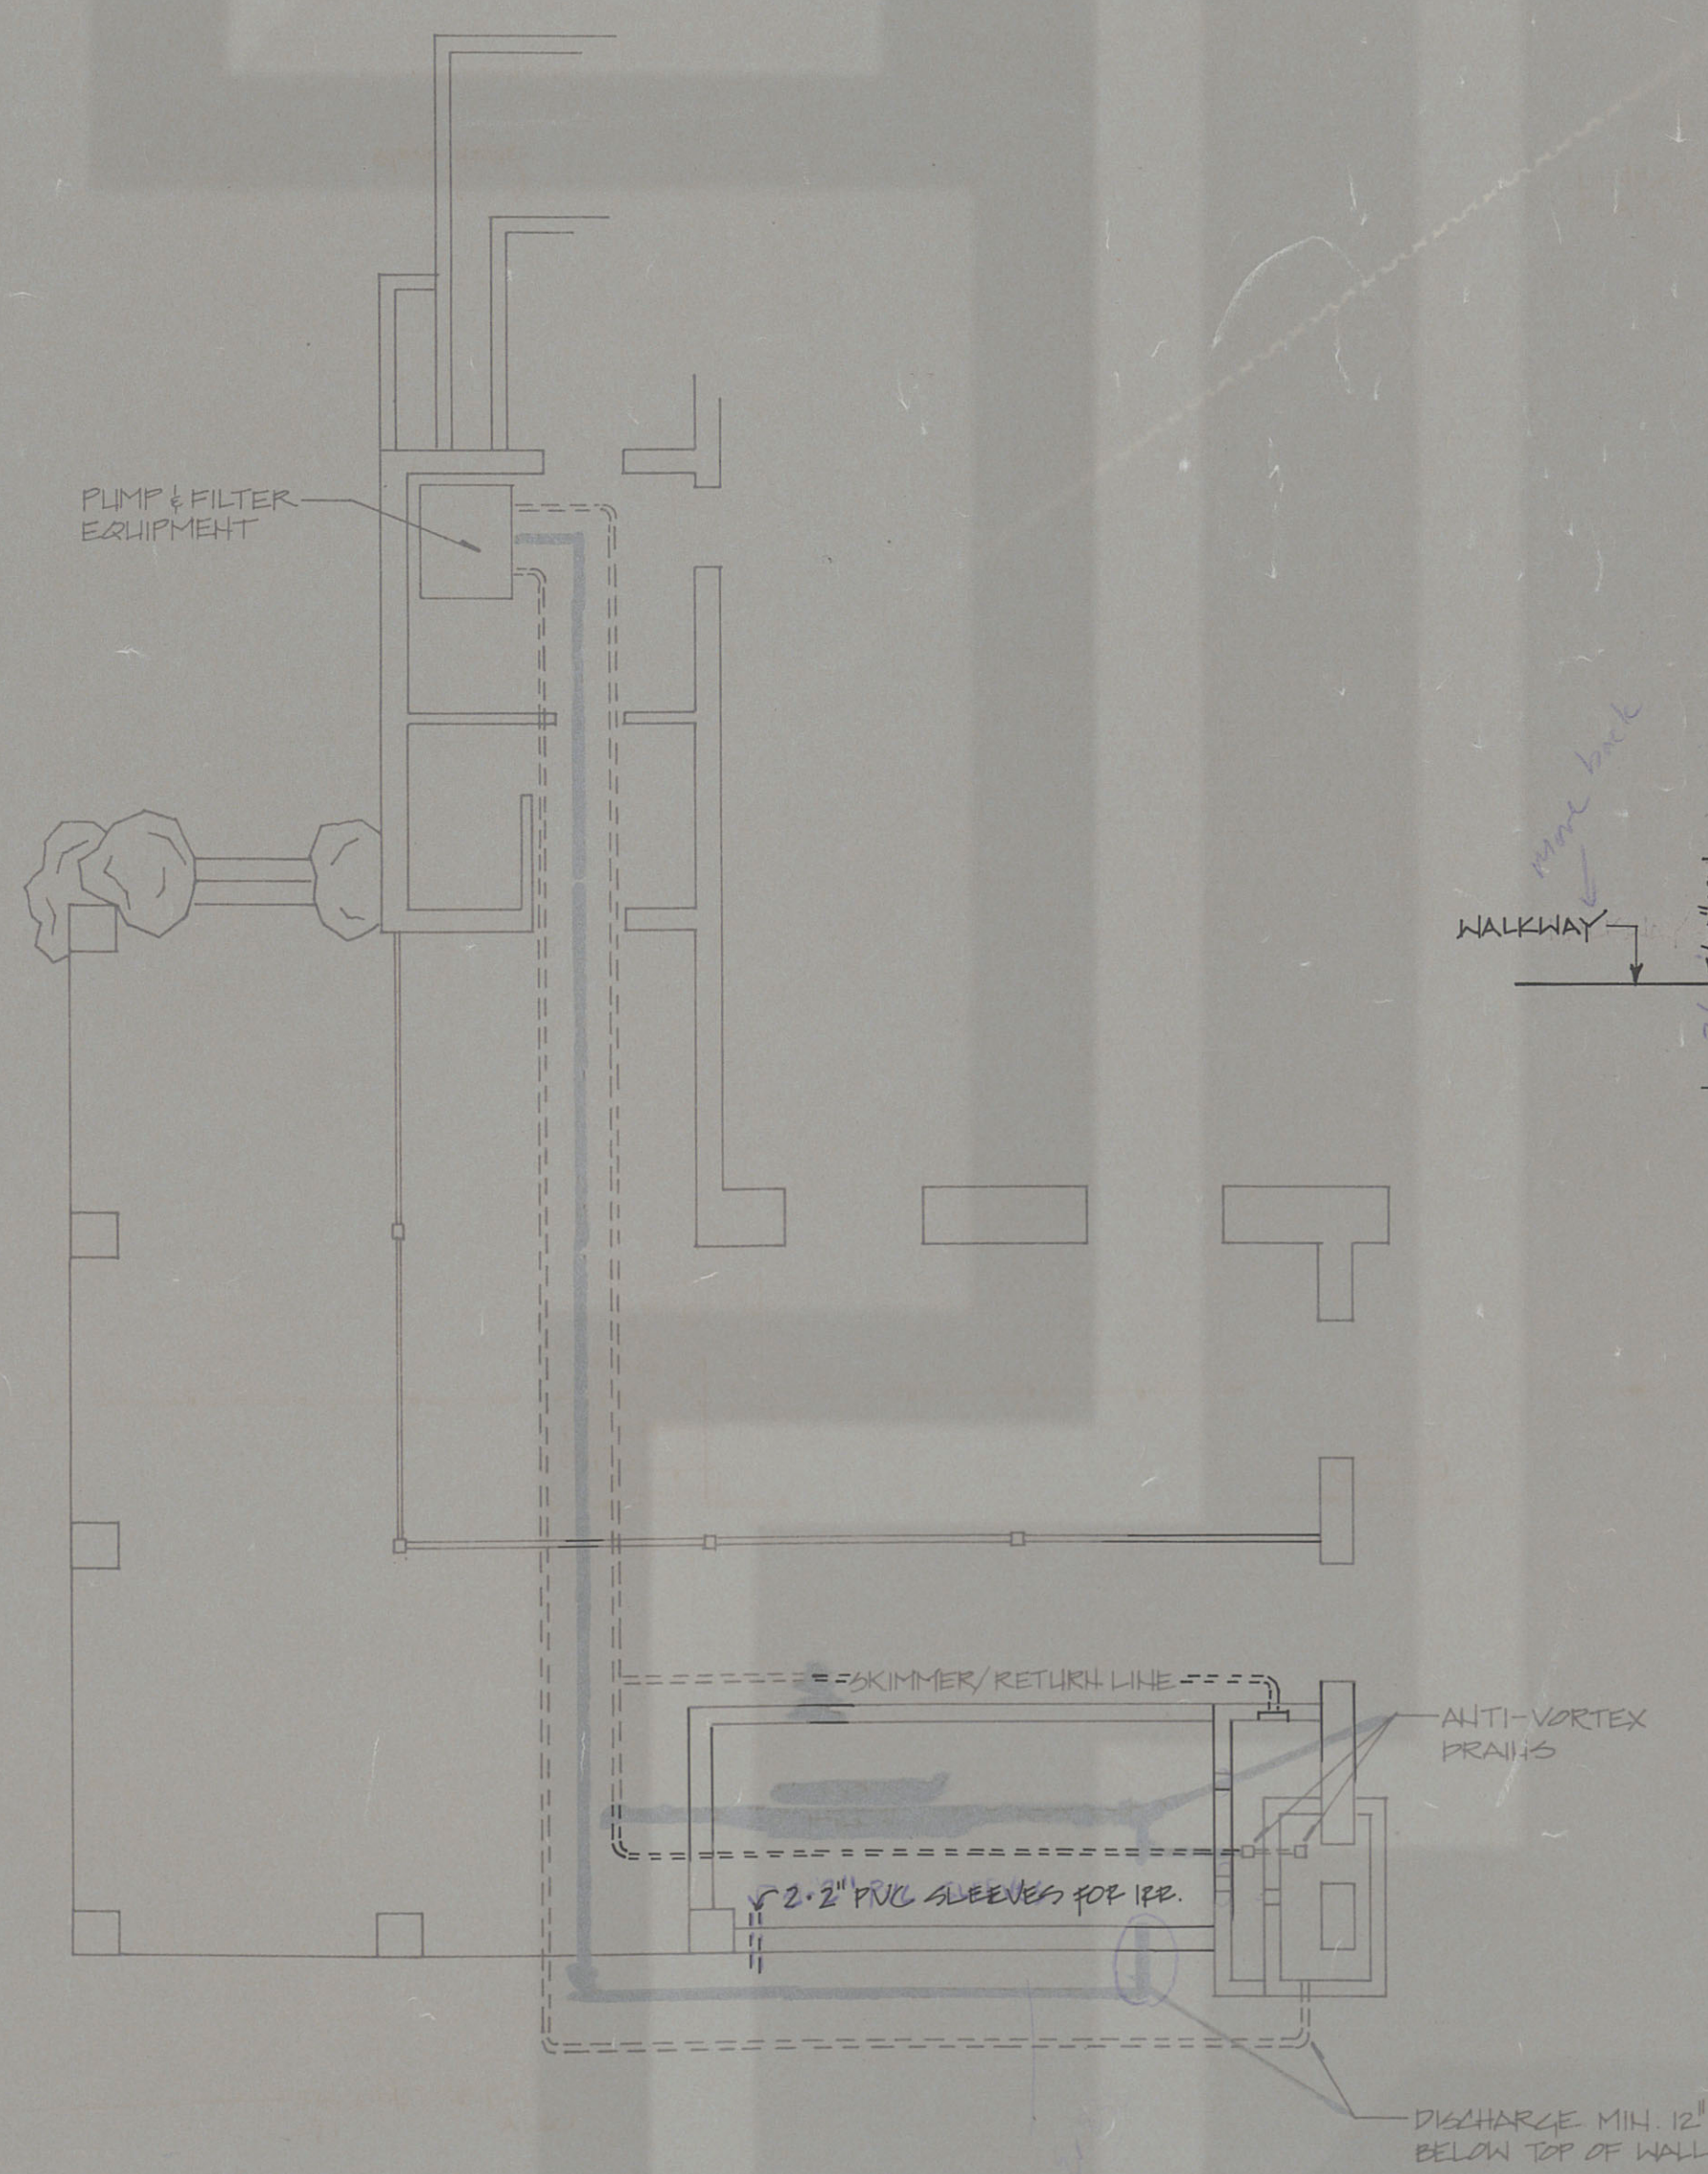


TEA ROOM WATER CASCADE PIPING PLAN

SCALE: 1/8" = 1'-0"

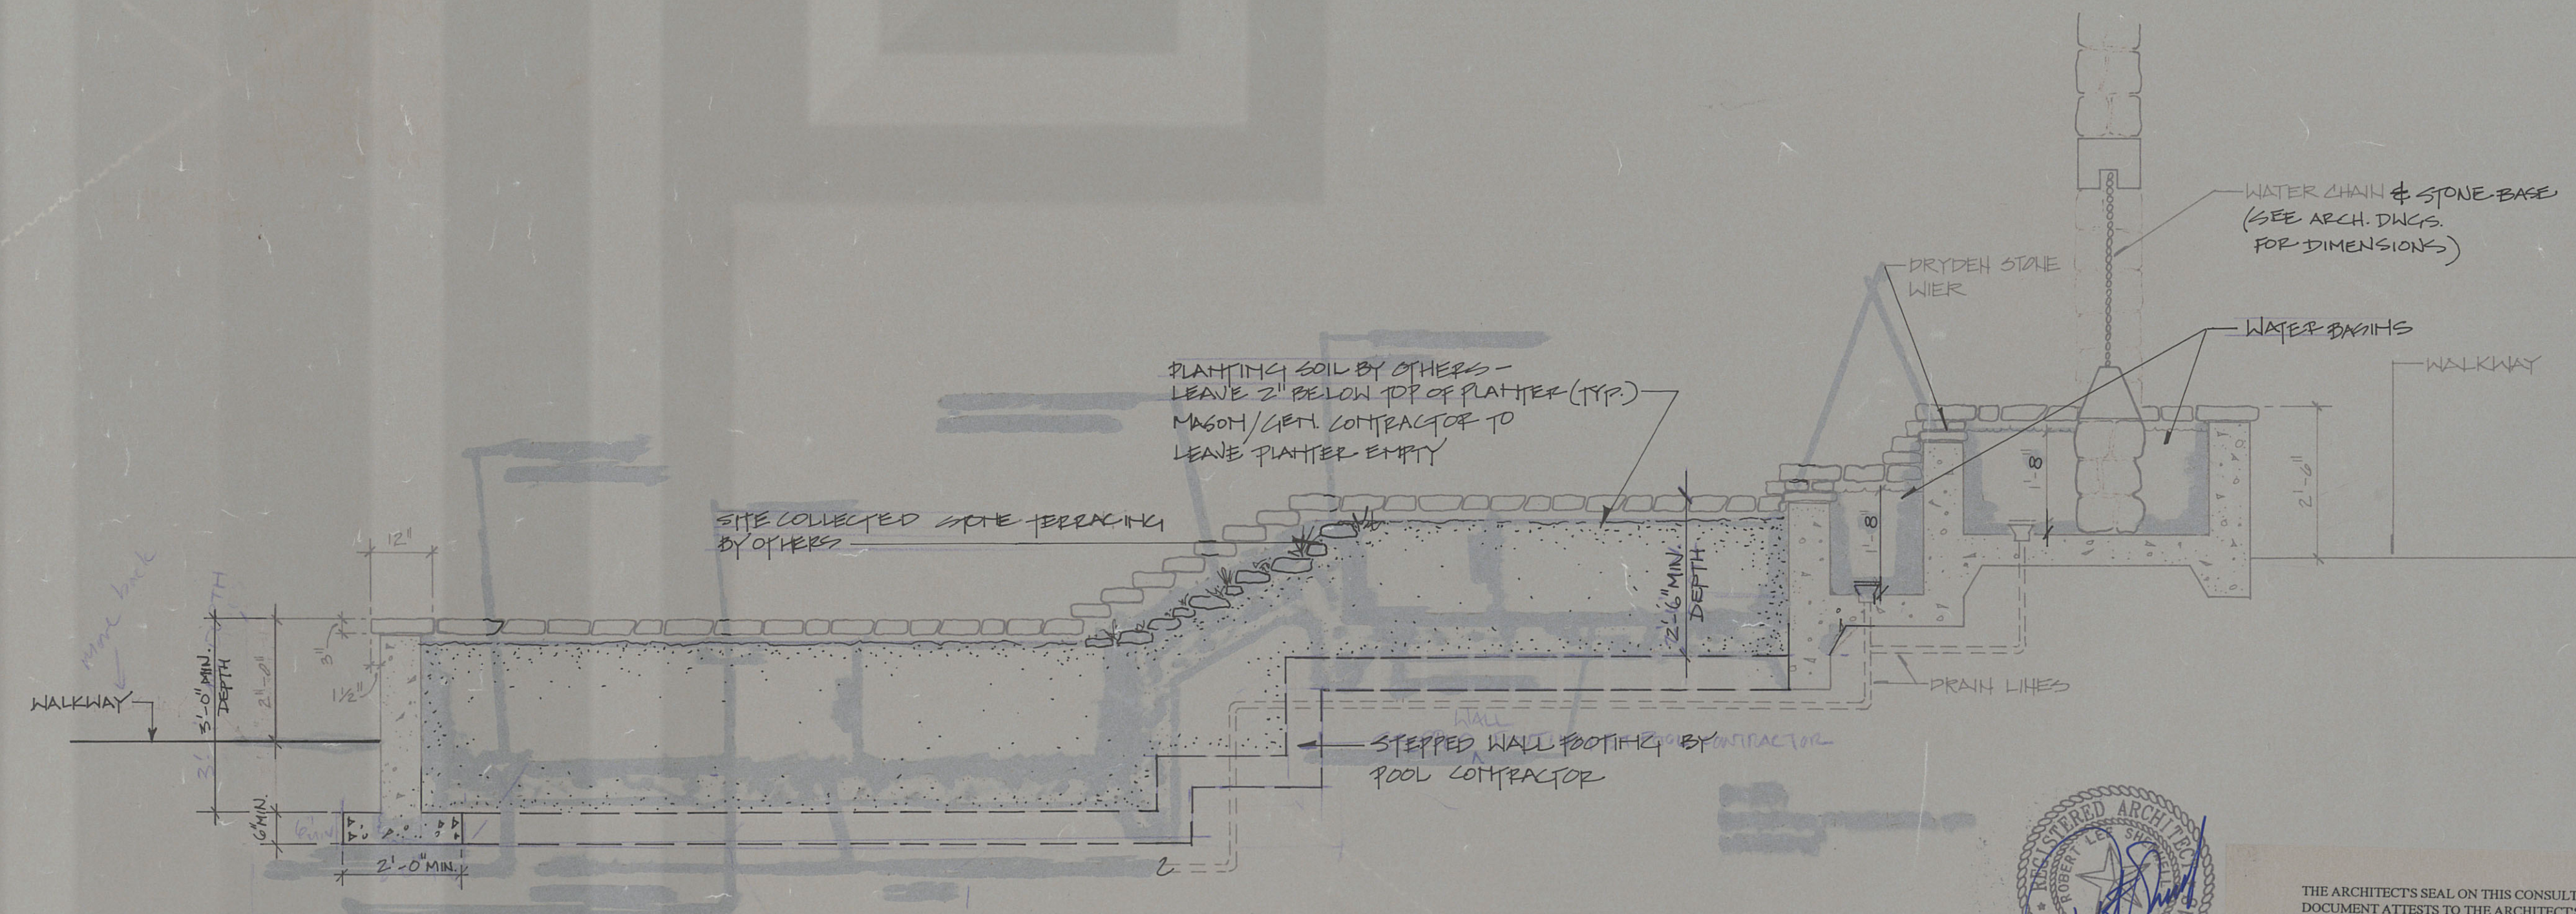


SECTION TEA ROOM WATER CASCADE and PLANTER

SCALE: 1/2" = 1'-0"

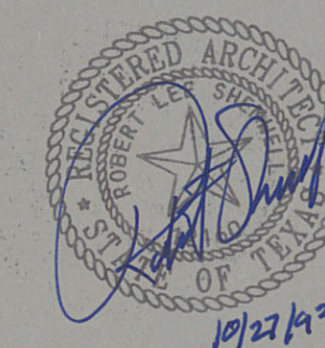

THE ARCHITECT'S SEAL ON THIS CONSULTANT'S DOCUMENT ATTESTS TO THE ARCHITECT'S COORDINATION OF THE CONSULTANT'S WORK WITH THAT OF THE ARCHITECT'S AND DOES NOT IMPLY THE ARCHITECT'S PRACTICE OF ENGINEERING OR OTHER CONSULTANTS SPECIALTY.

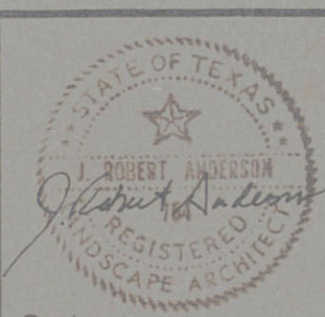

ISSUED FOR CONSTRUCTION 11/30/93
REVISED 1/11/94

7-26-93
Issued / Revised



J. ROBERT ANDERSON, ASLA
Landscape Architect
1135 W. Sixth Street, Suite 120
Austin, Texas 78703
(512) 476-1777

NATIONAL WILDFLOWER RESEARCH CENTER

Project Name: TEA ROOM WATER CASCADE PLAN + DETAILS
Project No.:
Drawing No.: L-10
Drawing Title: SCALE VARIES