

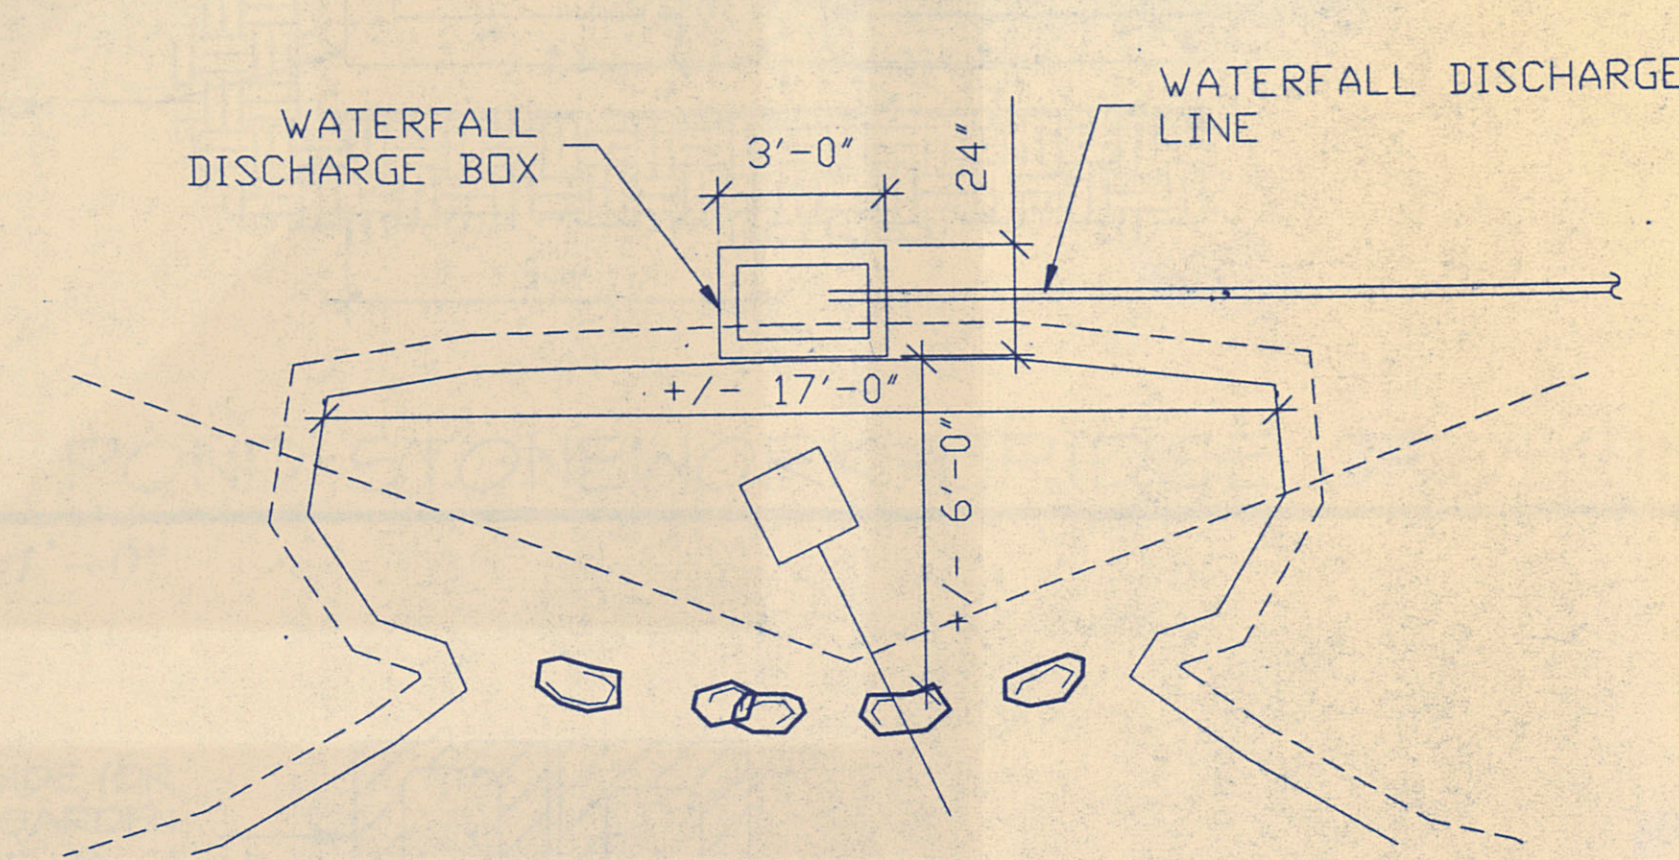


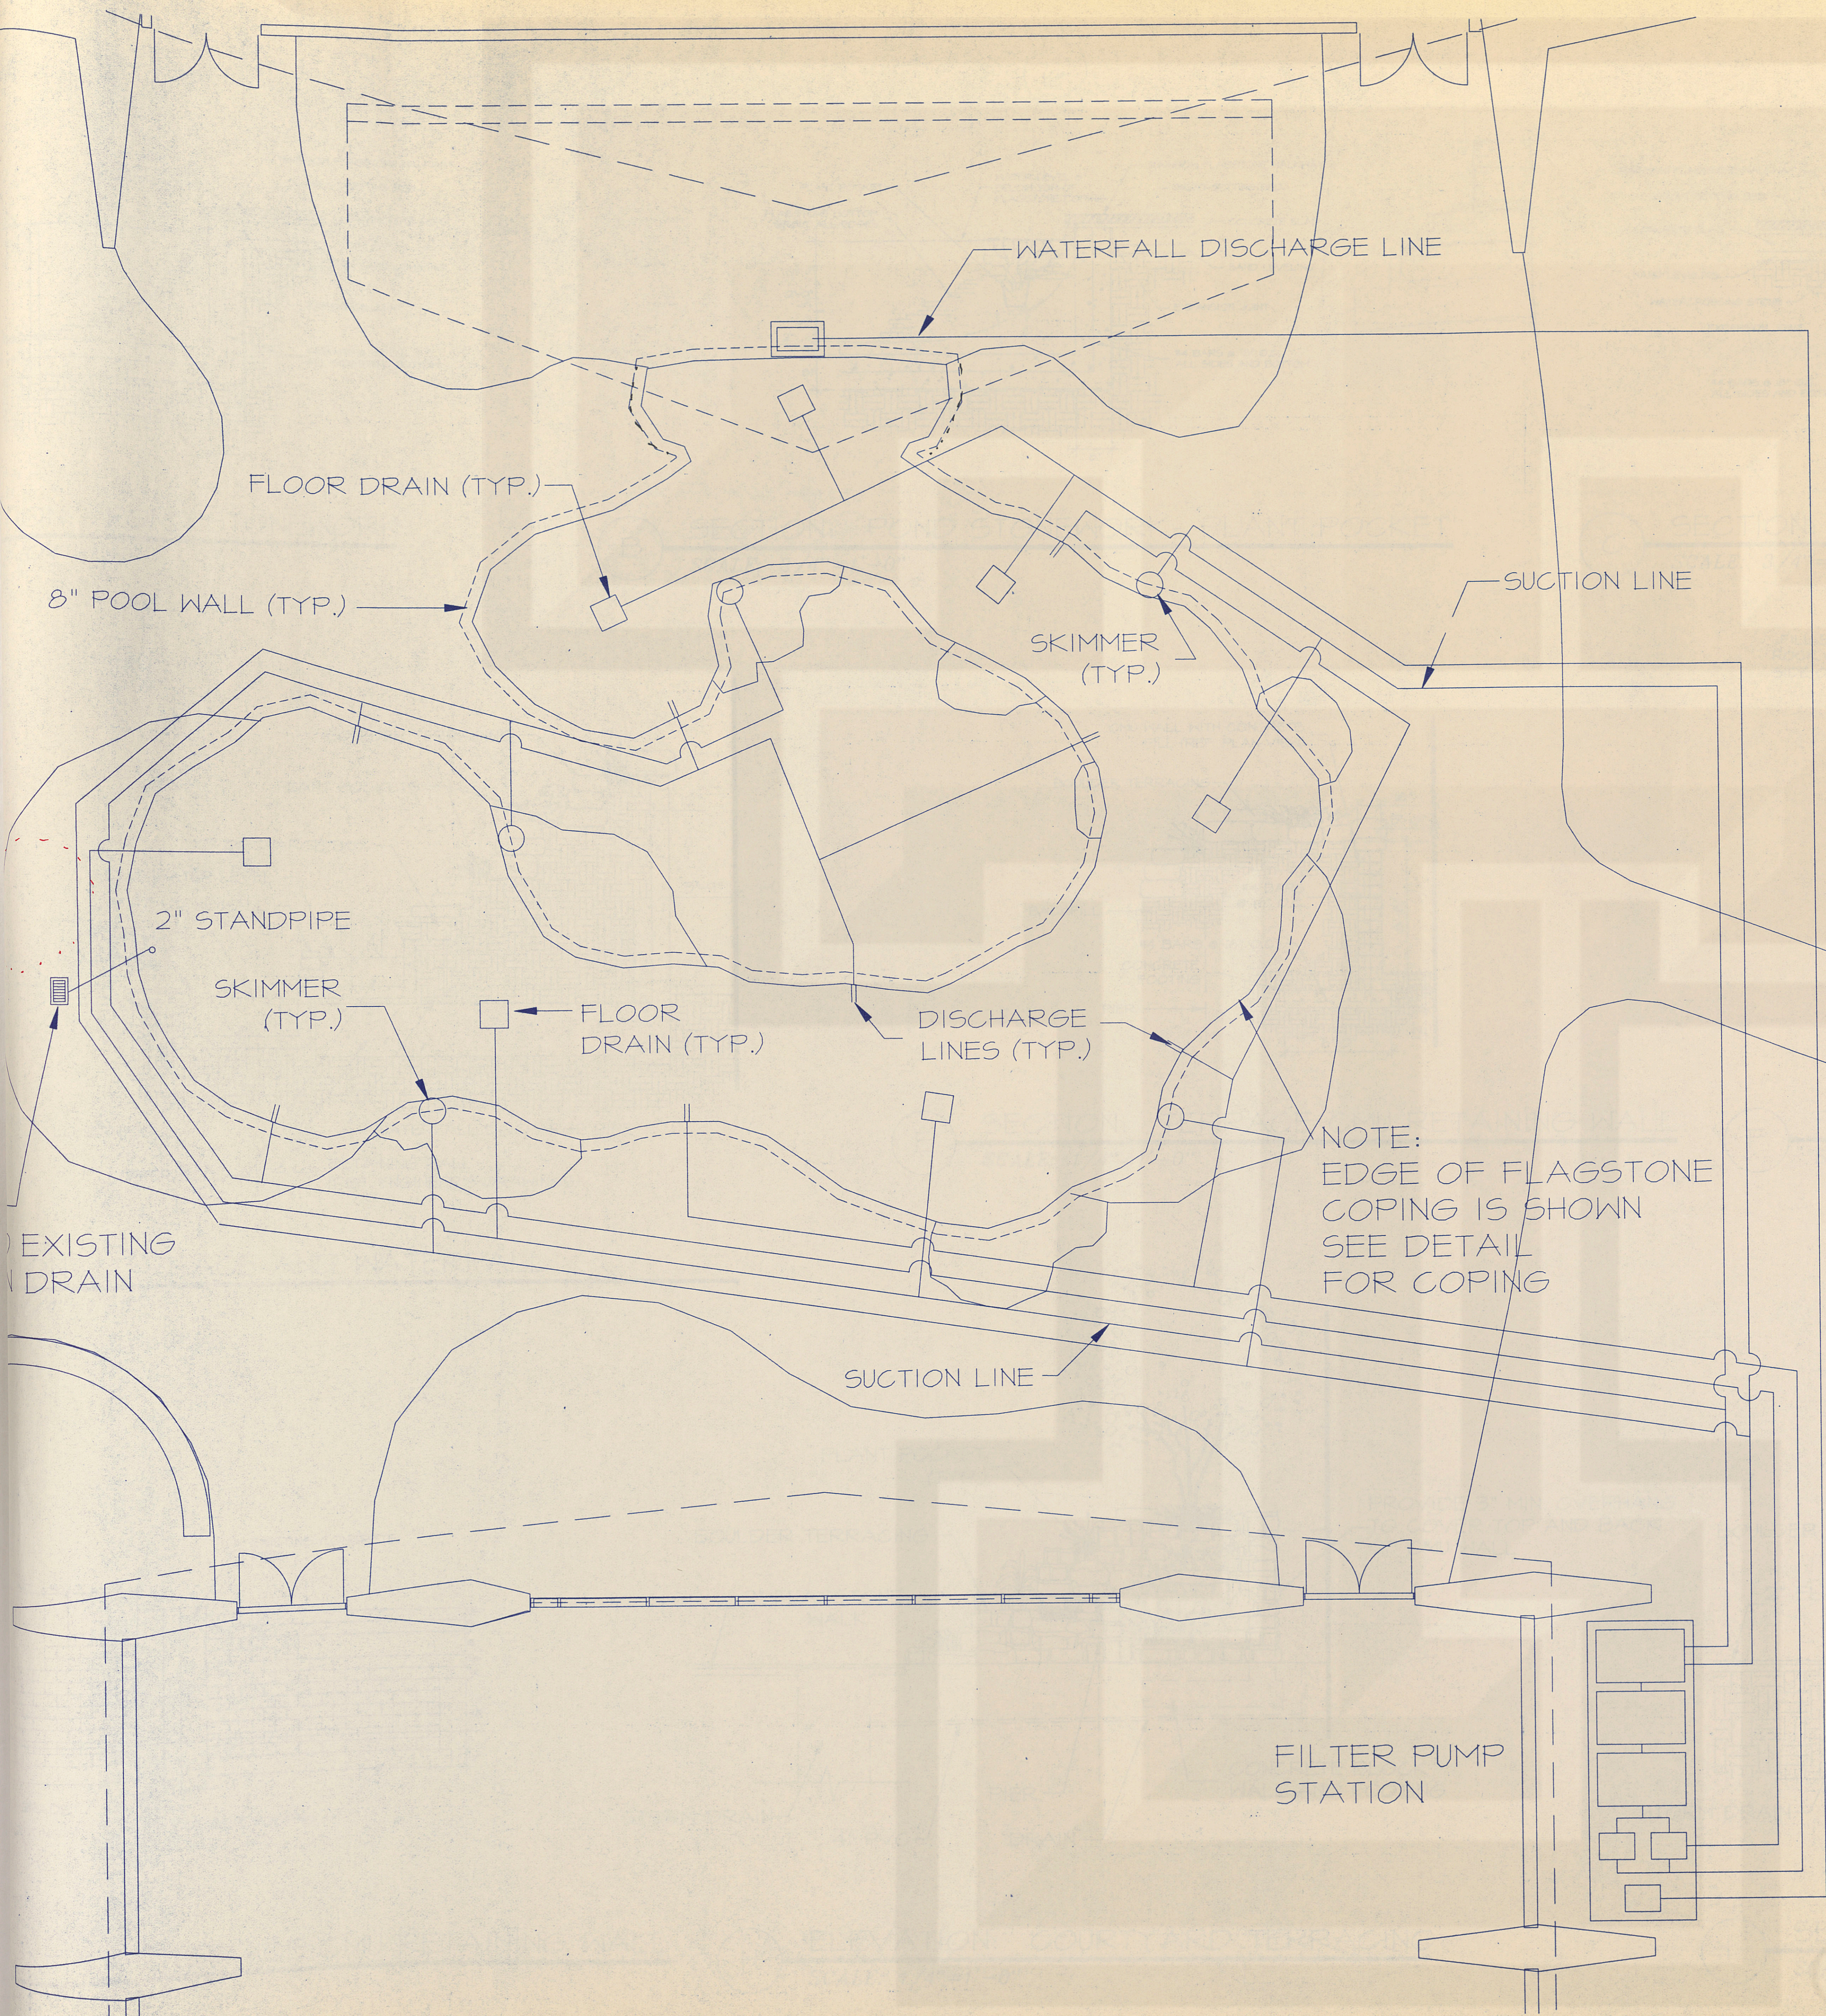

ENLARGED PLAN-WATERFALL
AND UPPER POND

NOT TO SCALE

NOTE:
EDGE OF FLAGSTONE
COPING IS SHOWN
SEE DETAIL
FOR COPING

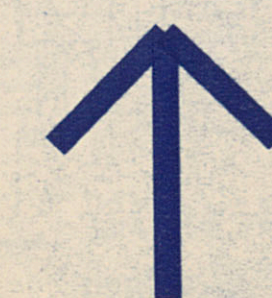

North

Scale: 1/4" = 1'-0"

POND PLUMBING PLAN

The National Cowboy Hall of Fame

The Norma Sutherland
Garden

J. Robert Anderson, ASLA
Landscape Architect
1715 S. Capital of TX Hwy. Ste. 105
Austin, TX 78746

Date: 08/15/97

Sheet: L-5