


RCP LEGEND

A	AXO - SKIRT - UP SKR 150, FLUORESCENT
B	AXO - SKIRT - UP SKR 120, FLUORESCENT
C	FLOS - SKYGAREN S - FUS41004 - WHITE, HALOGEN
D	NESSEN - N4256 TAVELL VORTI WALL SCONE ADA SATIN NICKEL, HALOGEN
E	BOYD - E10404 RESENT LANTERN LED SATIN NICKEL WITH OPTIONAL GOLDEN SATE ORANGE INTERIOR COLOR
F	BOYD - E10404 WALL (4), FLUORESCENT, SATIN NICKEL FINISH, MIRROR MOUNT MODIFICATION WITHOUT BACK PLATES
G	LIGHTLOST - LAPITE PENDANT, INCANDESCENT, MERCURY FINISH
H	DELTAUGHT - LEDS 50 IN FORTE 6 302 10 31
I	REZEK - 2.5 SQUARE SUSPENSION SYSTEM DIRECT + INDIRECT FLUORESCENT
J	LED OR FLUORESCENT DOWNLIGHT, T.B.D.
K	LED OR FLUORESCENT WALLWASHER, T.B.D.

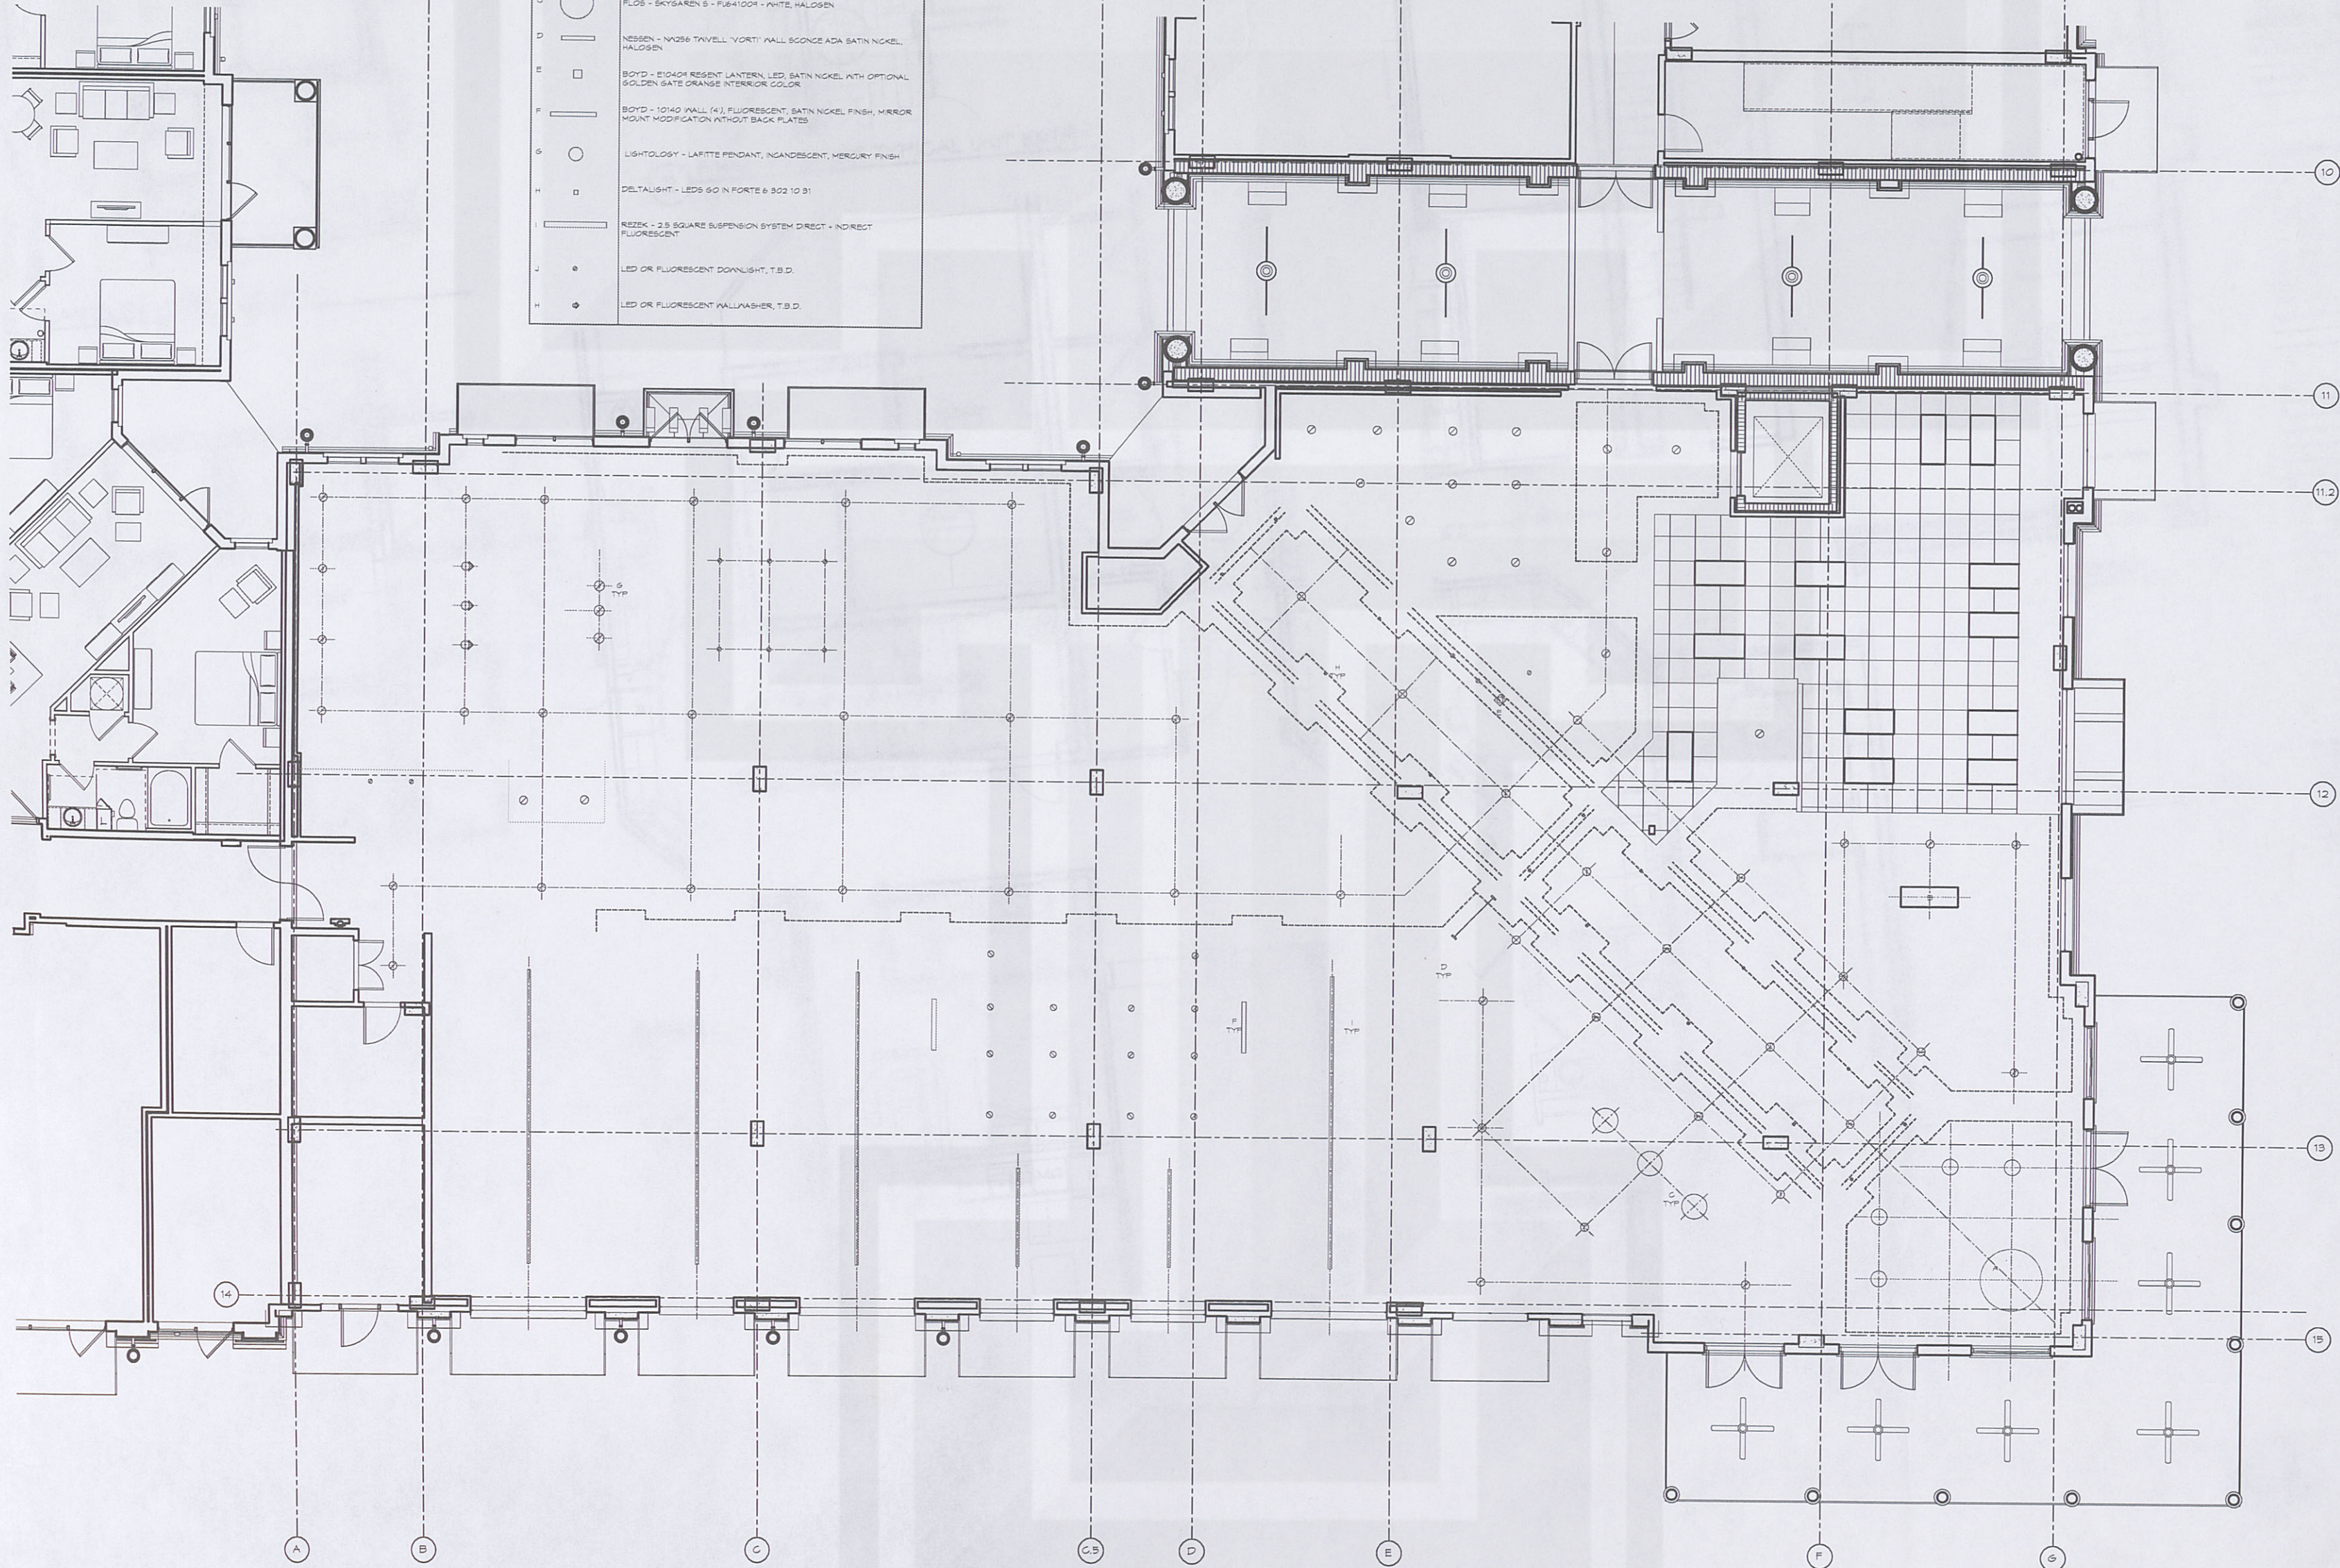

LRK

Looney Ricks Kiss

Architecture Planning Interiors Research
175 Toyota Plaza, Suite 600
Memphis, Tennessee 38103
Telephone 901.521.1440
Fax 901.525.2760
E-mail info@lrk.com

Client:

LOADSTAR, Inc.

9830 Colonnade Boulevard, Suite 600

San Antonio, Texas 78230

Issues

Date	Issues
06.28.2012	PRELIMINARY

06.08.12	
07.11.12	PERMIT SET

No. Date Revisions

8	10/15/12	For Construction Set
---	----------	----------------------

©2012 LRK Inc.
Drawings, written material, and design concepts shall not be used or reproduced in whole or part in any form or format without prior written consent of LRK Inc. Do not scale drawings. Use given dimensions only. If not shown, verify correct dimensions with the Architect. Contractor shall check and verify all dimensions and conditions at job site.

Seal



Project Number: 01.11073.00

Project Name:

La Cantera Mixed Use

6215 Via La Cantera
San Antonio, Texas 78256

Drawing Name:

Reflected Ceiling Plan Leasing and Amenity

Drawn By: BD, MF, DS

Checked By: BD, BE

A601

1 Leasing and Amenity
3/16" = 1'-0"